
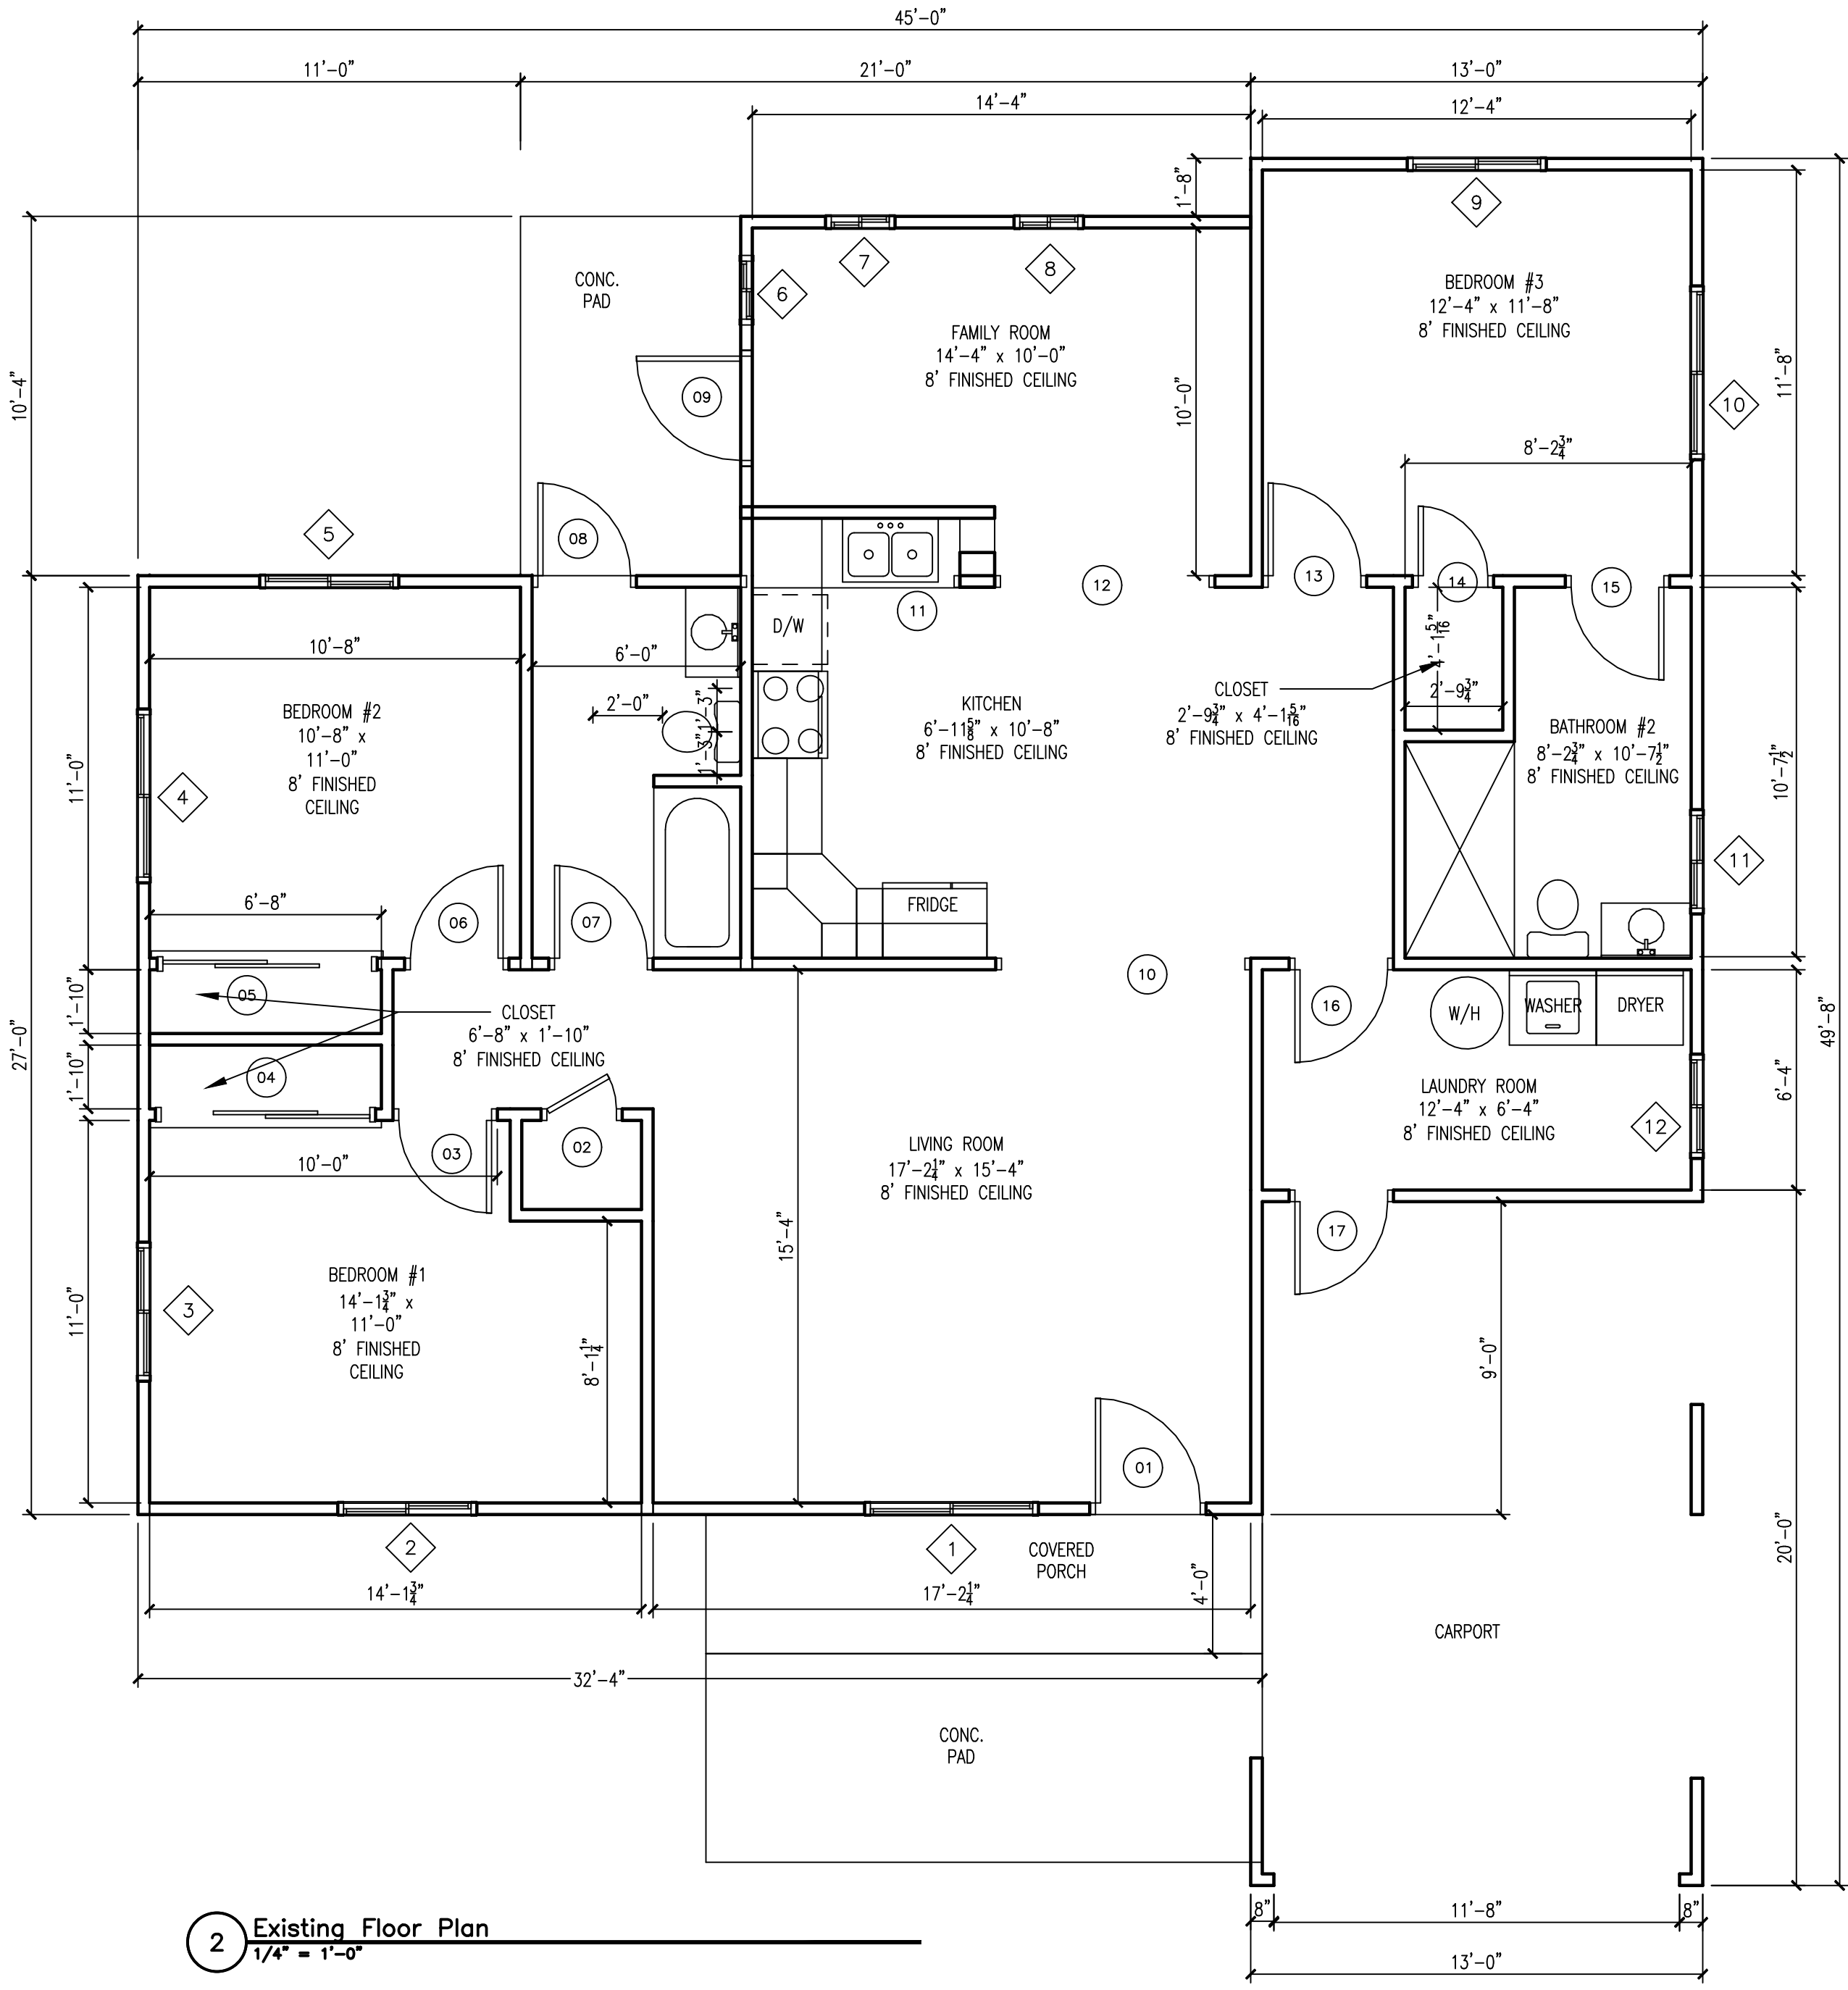


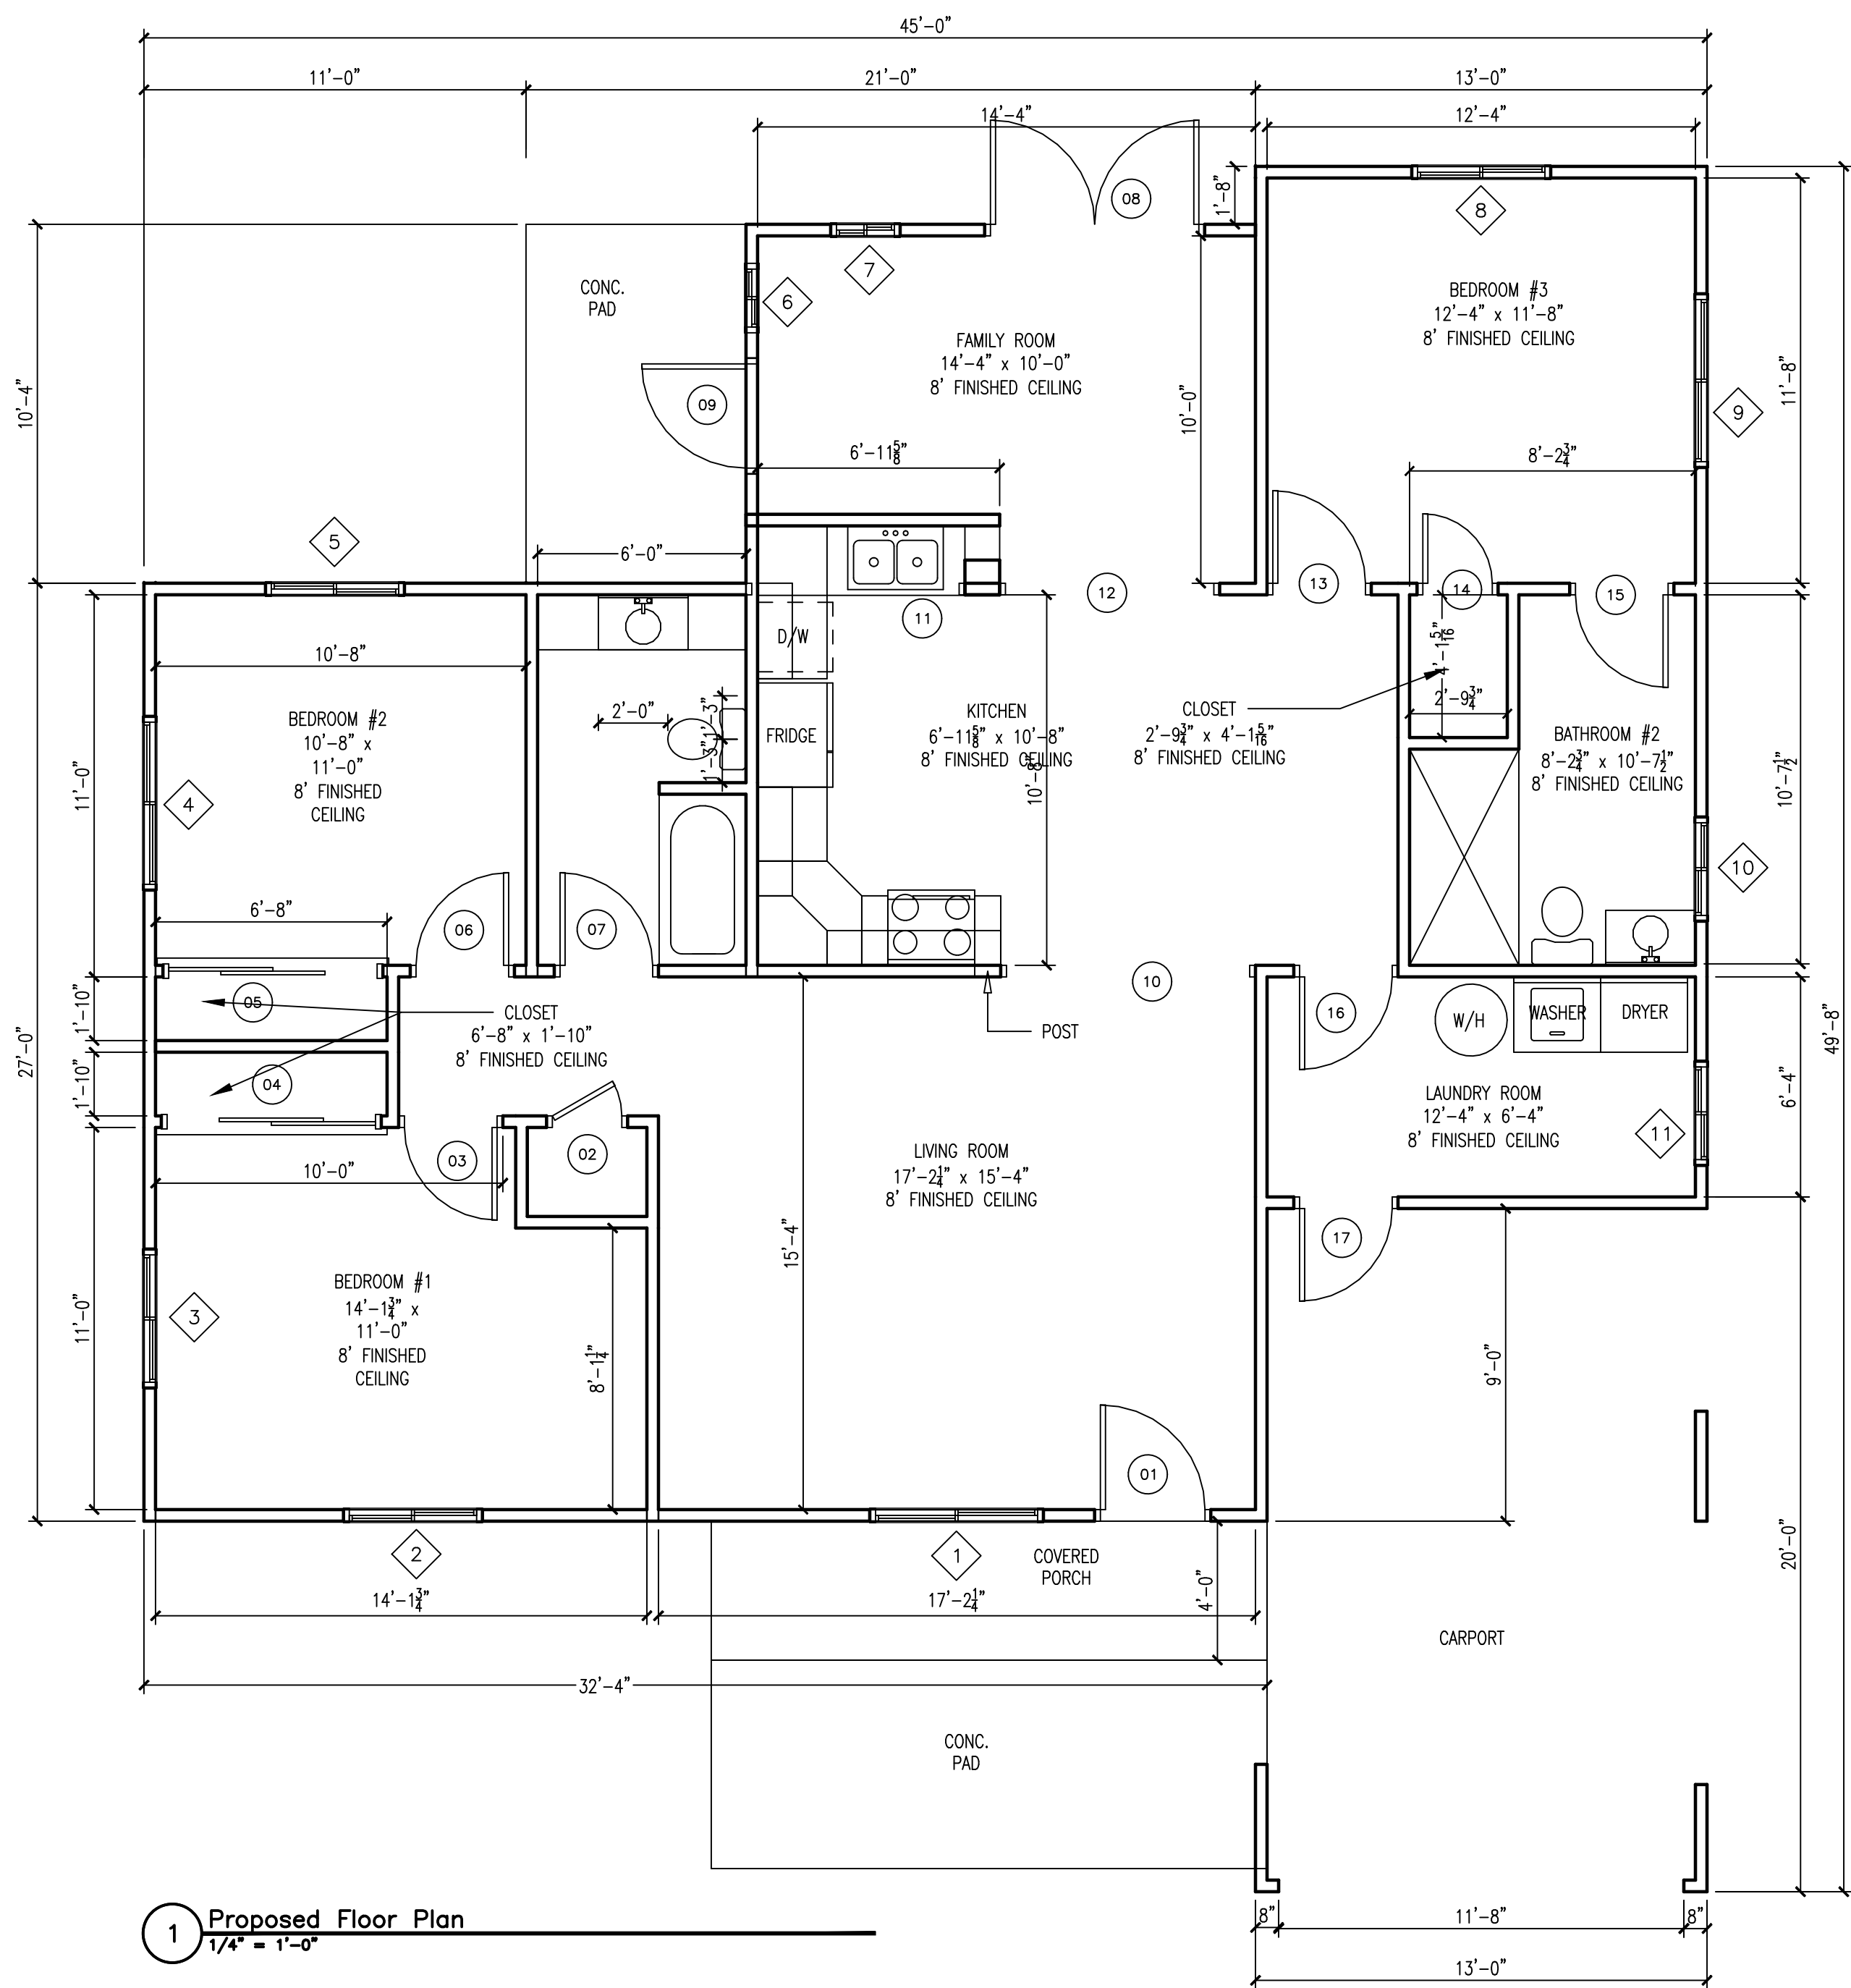

DOOR AND FRAME SCHEDULE					
MARK	DOOR SIZE			Head Height	Style
	WD	HGT	THK		
1	3'-0 1/8"	6'-8"	1 3/4"	6'-8"	Hinged - Single
2	2'-0"	6'-8"	1 3/4"	6'-8"	Hinged - Single
3	2'-8"	6'-8"	1 3/4"	6'-8"	Hinged - Single
4	6'-0"	6'-8"	1 1/4"	6'-8"	Sliding - Double - Full Lite
5	6'-0"	6'-8"	1 1/4"	6'-8"	Sliding - Double - Full Lite
6	2'-8"	6'-8"	1 3/4"	6'-8"	Hinged - Single
7	2'-8"	6'-8"	1 3/4"	6'-8"	Hinged - Single
8	6'-0"	6'-8"	1 3/4"	6'-8"	Hinged - Double
9	3'-0"	6'-8"	1 3/4"	6'-8"	Hinged - Single
10	7'-0"	7'-5"	NA	7'-5"	Cased Opening
11	8'-11 5/8"	7'-5"	NA	7'-5"	Cased Opening
12	6'-0"	7'-5"	NA	7'-5"	Cased Opening
13	2'-8"	6'-8"	1 3/4"	6'-8"	Hinged - Single
14	2'-0"	6'-8"	1 3/4"	6'-8"	Hinged - Single
15	2'-8"	6'-8"	1 3/4"	6'-8"	Hinged - Single
16	2'-8"	6'-8"	1 3/4"	6'-8"	Hinged - Single
17	2'-8"	6'-8"	1 3/4"	6'-8"	Hinged - Single

MARK	WINDOW SIZE		Head Height	Style	NOTES
	Width	HEIGHT			
1	5'-0"	4'-0"	6'-8"	Glider	
2	4'-0"	4'-0"	6'-8"	Glider	
3	4'-0"	4'-0"	6'-8"	Glider	
4	5'-0"	3'-0"	6'-8"	Glider	
5	4'-0"	4'-0"	6'-8"	Glider	
6	2'-0"	3'-0"	6'-8"	Glider	
7	2'-0"	3'-0"	6'-8"	Glider	
8	4'-0"	4'-0"	6'-8"	Glider	
9	5'-0"	3'-0"	6'-8"	Glider	
10	3'-0"	3'-0"	6'-8"	Glider	
11	3'-0"	3'-0"	6'-8"	Glider	

DOOR AND FRAME SCHEDULE					
MARK	DOOR SIZE			Head Height	Style
	WD	HGT	THK		
1	3'-0 1/8"	6'-8"	1 3/4"	6'-8"	Hinged - Single
2	2'-0"	6'-8"	1 3/4"	6'-8"	Hinged - Single
3	2'-8"	6'-8"	1 3/4"	6'-8"	Hinged - Single
4	6'-0"	6'-8"	1 1/4"	6'-8"	Sliding - Double - Full Lite
5	6'-0"	6'-8"	1 1/4"	6'-8"	Sliding - Double - Full Lite
6	2'-8"	6'-8"	1 3/4"	6'-8"	Hinged - Single
7	2'-8"	6'-8"	1 3/4"	6'-8"	Hinged - Single
8	2'-8"	6'-8"	1 3/4"	6'-8"	Hinged - Single
9	3'-0"	6'-8"	1 3/4"	6'-8"	Hinged - Single
10	7'-0"	7'-5"	NA	7'-5"	Cased Opening
11	8'-11 5/8"	7'-5"	NA	7'-5"	Cased Opening
12	6'-0"	7'-5"	NA	7'-5"	Cased Opening
13	2'-8"	6'-8"	1 3/4"	6'-8"	Hinged - Single
14	2'-0"	6'-8"	1 3/4"	6'-8"	Hinged - Single
15	2'-8"	6'-8"	1 3/4"	6'-8"	Hinged - Single
16	2'-8"	6'-8"	1 3/4"	6'-8"	Hinged - Single
17	2'-8"	6'-8"	1 3/4"	6'-8"	Hinged - Single

MARK	WINDOW SIZE		Head Height	Style	NOTES
	Width	HEIGHT			
1	5'-0"	4'-0"	6'-8"	Glider	
2	4'-0"	4'-0"	6'-8"	Glider	
3	4'-0"	4'-0"	6'-8"	Glider	
4	5'-0"	3'-0"	6'-8"	Glider	
5	4'-0"	4'-0"	6'-8"	Glider	
6	2'-0"	3'-0"	6'-8"	Glider	
7	2'-0"	3'-0"	6'-8"	Glider	
8	2'-0"	3'-0"	6'-8"	Glider	
9	4'-0"	4'-0"	6'-8"	Glider	
10	5'-0"	3'-0"	6'-8"	Glider	
11	3'-0"	3'-0"	6'-8"	Glider	
12	3'-0"	3'-0"	6'-8"	Glider	

PROJECT NAME:
As-Built
2633 NW 9th Ln.
Wilton Manors, FL 33311

DESIGNER:

HISTORY RECORD:

NO.: DATE: DESCRIPTION:

B&S STAMP:

As-Built
2633 NW 9th Ln.
Wilton Manors, FL 33311

OWNERSHIP AND USE OF DOCUMENTS
THIS DRAWING IS THE PROPERTY OF MEI U HOMES LLC. A
CALIFORNIA LIMITED LIABILITY COMPANY AND SHALL NOT BE USED OR
REPRODUCED WITHOUT WRITTEN CONSENT. ALL RIGHTS RESERVED.

DATE: 10/23/25

PROJECT NO.: D0056 BroWiM009263

DRAWN BY:

REVIEWED BY:


SCALE: 1/2" = 1'-0"

SHEET TITLE:

Proposed & Existing
Remodel Floor Plan

SHEET NO.:

A-02

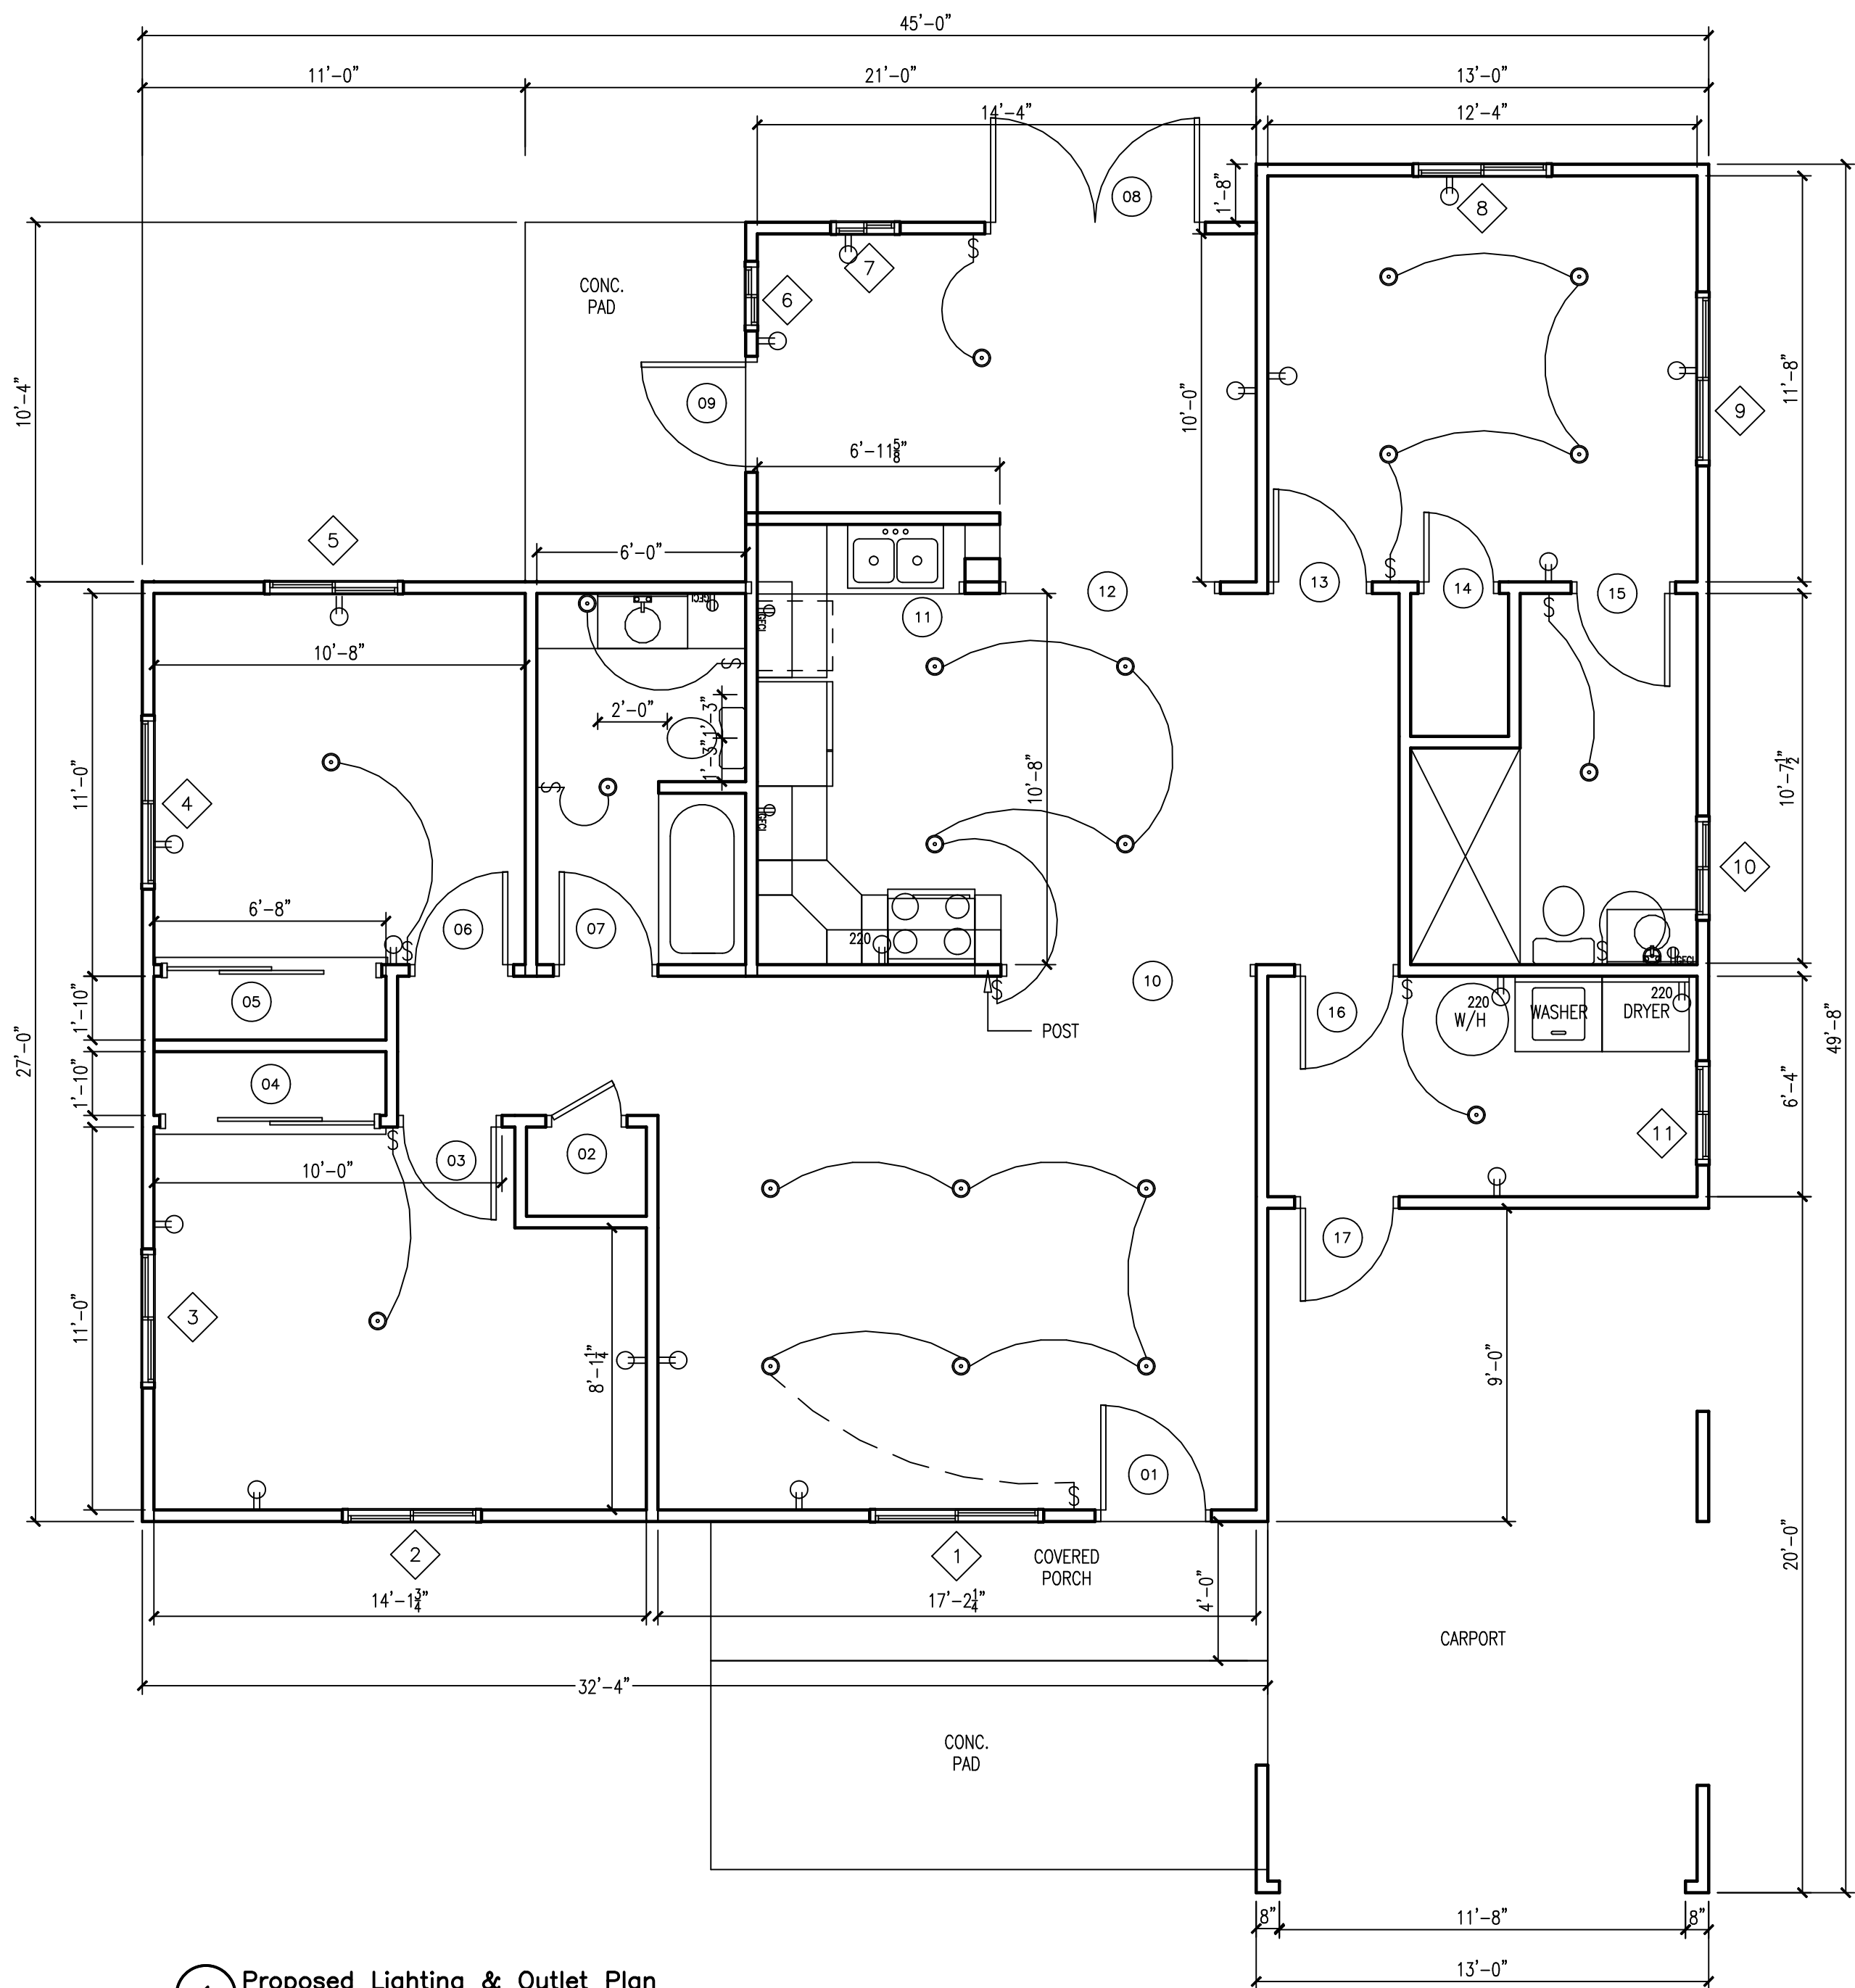

ELECTRICAL LEGEND	
	DUPLEX OUTLET
	DIMMER WALL SWITCH
	GARBAGE DISPOSAL SWITCH
	VACANCY SENSOR SWITCH
	4" DIA DRYER VENT
	HIGH EFFICACY RECESSED LIGHT
	EXTERIOR PORCH LIGHT
	FAN AND LIGHT COMBINATION
	CARBON MONOXIDE ALARM
	SMOKE DETECTOR
	GFCI/AFCI OUTLET
	DATA
	220V OUTLET
	MANUAL ON/OFF SWITCH
— — CONNECTION B/W LIGHTING OUTLET & INDICATED SWITCH	

PROJECT NAME:
As-Built
2633 NW 9th Ln.
Wilton Manors, FL 33311

DESIGNER:

HISTORY RECORD:

NO.: DATE: DESCRIPTION:

B&S STAMP:

As-Built
2633 NW 9th Ln.
Wilton Manors, FL 33311

OWNERSHIP AND USE OF DOCUMENTS
THIS DRAWING IS THE PROPERTY OF MEI LI HOMES LLC, A CALIFORNIA LIMITED LIABILITY COMPANY AND SHALL NOT BE USED OR REPRODUCED WITHOUT WRITTEN CONSENT. ALL RIGHTS RESERVED.

DATE: 10/23/25

PROJECT NO.: D0056 BroWiM009263

DRAWN BY: Dominique Higgins

REVIEWED BY: Dominique Higgins

SCALE: 3/8" = 1'-0"

SHEET TITLE:

M.E.P Details for
Reference Only

SHEET NO.:

A-03

SHEET #

OF

-